

SHINGLEMILL APARTMENTS

ROCKLAND MASSACHUSETTS

LANDSCAPE PLANS

SHEET LIST	
CS	COVER SHEET
L0.0	LANDSCAPE PLAN
L0.1	LANDSCAPE ENLARGEMENT PLAN
L0.2	PLANTING & AMENITIES BOARD
LP1.0	OVERALL PLANTING PLAN
LP1.1	PLANTING ENLARGEMENT PLAN 1
LP1.2	PLANTING ENLARGEMENT PLAN 2
LE1.0	SITE LIGHTING PLAN 1
LE1.1	SITE LIGHTING PLAN 2



TRAVERSE

landscape architects

150 Chestnut Street, 4th Floor
Providence, RI 02903

STAMP




PROJECT NAME

SHINGLEMILL APARTMENTS

PROJECT ADDRESS

75-79 POND STREET
ROCKLAND, MA 02370

NO.	REVISIONS	DATE
1	ENGINEERING EDITS	9/23/2022
	ENGINEERING EDITS	7/21/2023
SUBMITTAL		DATE
DRAN BY A JL		CHECKED BY A KB
DATE ISSUED A JULY 2023		SCALE A
PROJ. NO. R1018.1		
SHEET TITLE COVER SHEET		
SHEET NO. CS		

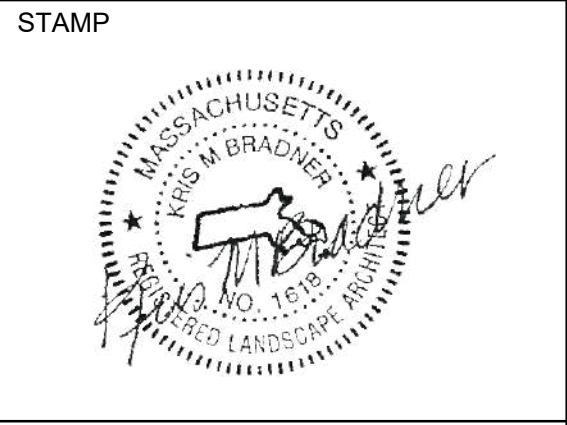

PROJECT NAME

SHINGLEMILL
APARTMENTS

PROJECT ADDRESS

75-79 POND STREET
ROCKLAND, MA 02370

NO.	REVISIONS	DATE
1	ENGINEERING EDITS	9/23/2022
	ENGINEERING EDITS	7/21/2023
SUBMITTAL		DATE

DRAWN BY JL	CHECKED BY KB
DATE ISSUED JULY 2023	SCALE 1" = 60'

PROJ. NO. R1018.1

SHEET TITLE

LANDSCAPE PLAN

SHEET NO.

L0.0



STAMP



PROJECT NAME

**SHINGLEMILL
APARTMENTS**

PROJECT ADDRESS

75-79 POND STREET
ROCKLAND, MA 02370

NO.	REVISIONS	DATE
1	ENGINEERING EDITS	9/23/2022
2	ENGINEERING EDITS	7/21/2023
3		
4		
5		

SUBMITTAL

DATE

DRAWN BY

JL

CHECKED BY

KB

DATE ISSUED

JULY 2023

SCALE

1" = 30'

PROJ. NO.

R1018.1

SHEET TITLE

**LANDSCAPE
ENLARGEMENT
PLAN**

SHEET NO.

L0.1

TREES, SHRUBS, AND PERENNIALS



RED MAPLE



GREY BIRCH



HONEY LOCUST



JUNIPER




HYDRANGEA



FOUNTAIN GRASS



RED TWIG DOGWOOD

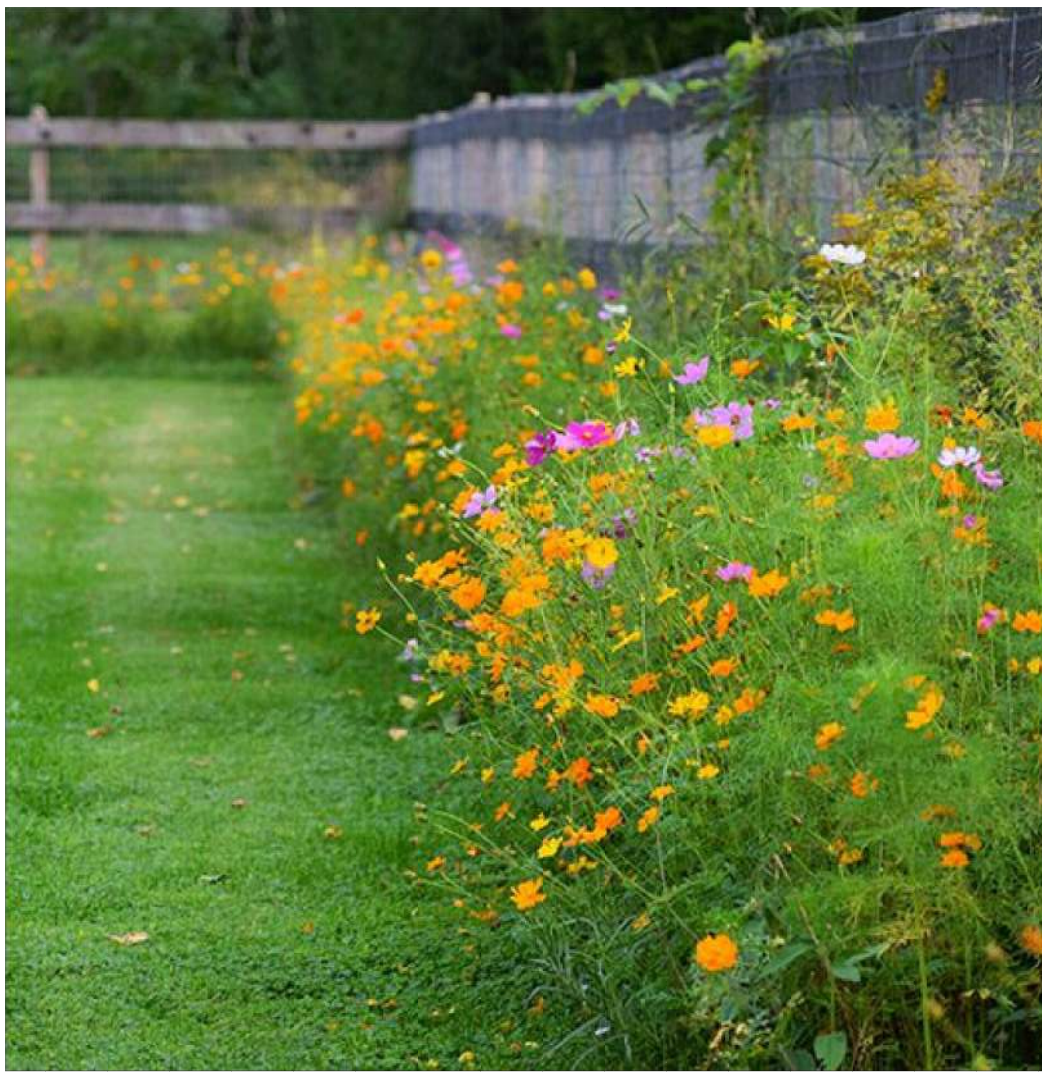

WILDFLOWER SEED MIX



BLUE POINT JUNIPER



FERN

SITE AMENITIES




SHADE STRUCTURE




ORNAMENTAL RECEPTACLES/BIKE RACK



ORNAMENTAL BENCH

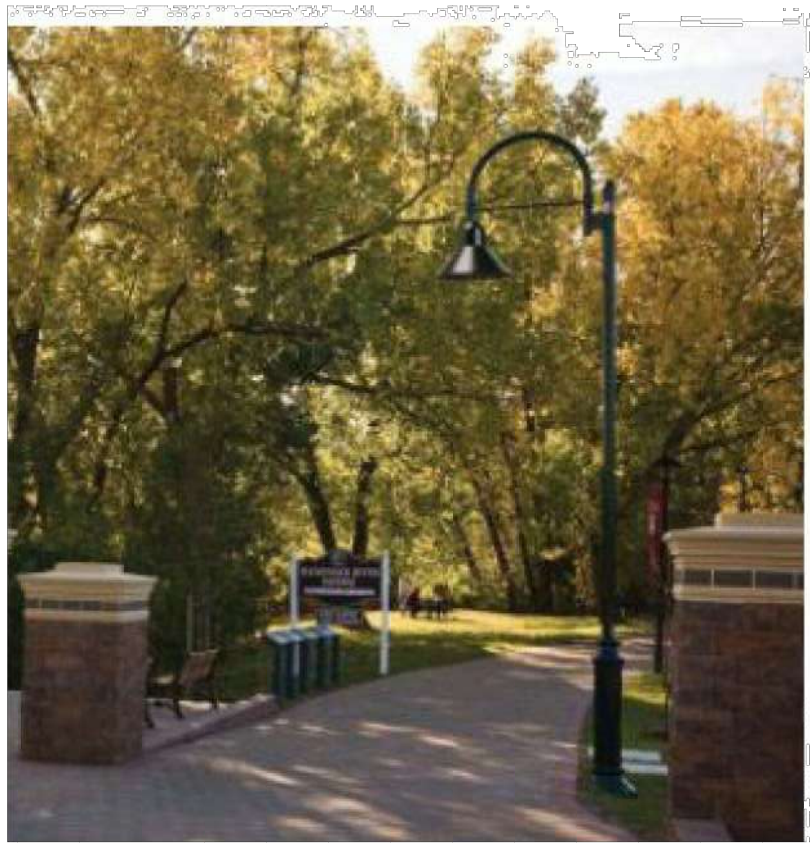

SITE LIGHTING

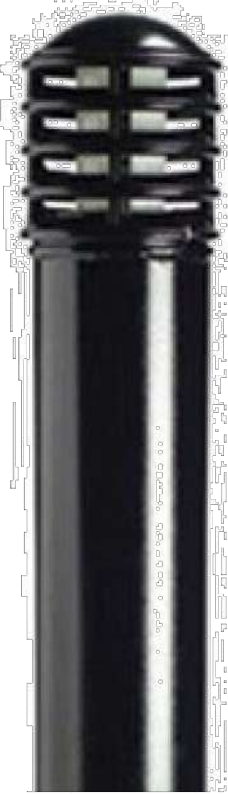

OUTDOOR GRILLING



PLAY STRUCTURE



SWINGS

STAMP



PROJECT NAME

SHINGLEMILL
APARTMENTS

PROJECT ADDRESS

75-79 POND STREET
ROCKLAND, MA 02370

NO.	REVISIONS	DATE
1	ENGINEERING EDITS	9/23/2022
	ENGINEERING EDITS	7/21/2023

SUBMITTAL

DATE

DRAN BY A
JL

CHECKED BY A
KB

DATE ISSUED A

JULY 2023

SCALE A

PROJ. NO.


R1018.1

SHEET TITLE

PLANTING &
AMENITIES BOARD

SHEET NO.

L0.2

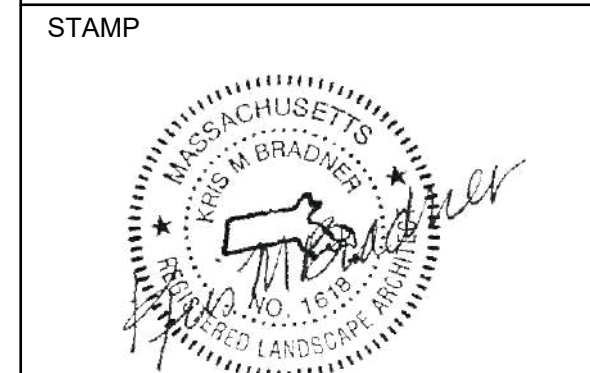

PROJECT NAME

SHINGLEMILL
APARTMENTS

PROJECT ADDRESS

75-79 POND STREET
ROCKLAND, MA 02370

NO.	REVISIONS	DATE
1	ENGINEERING EDITS	9/23/2022
	ENGINEERING EDITS	7/21/2023

SUBMITTAL

DATE

DRAWN BY:
JL

CHECKED BY:
KB

DATE ISSUED:
JULY 2023

SCALE:
1" = 30'


PROJ. NO.
R1018.1

SHEET TITLE

SITE LIGHTING
PLAN 1

SHEET NO.


LE1.0

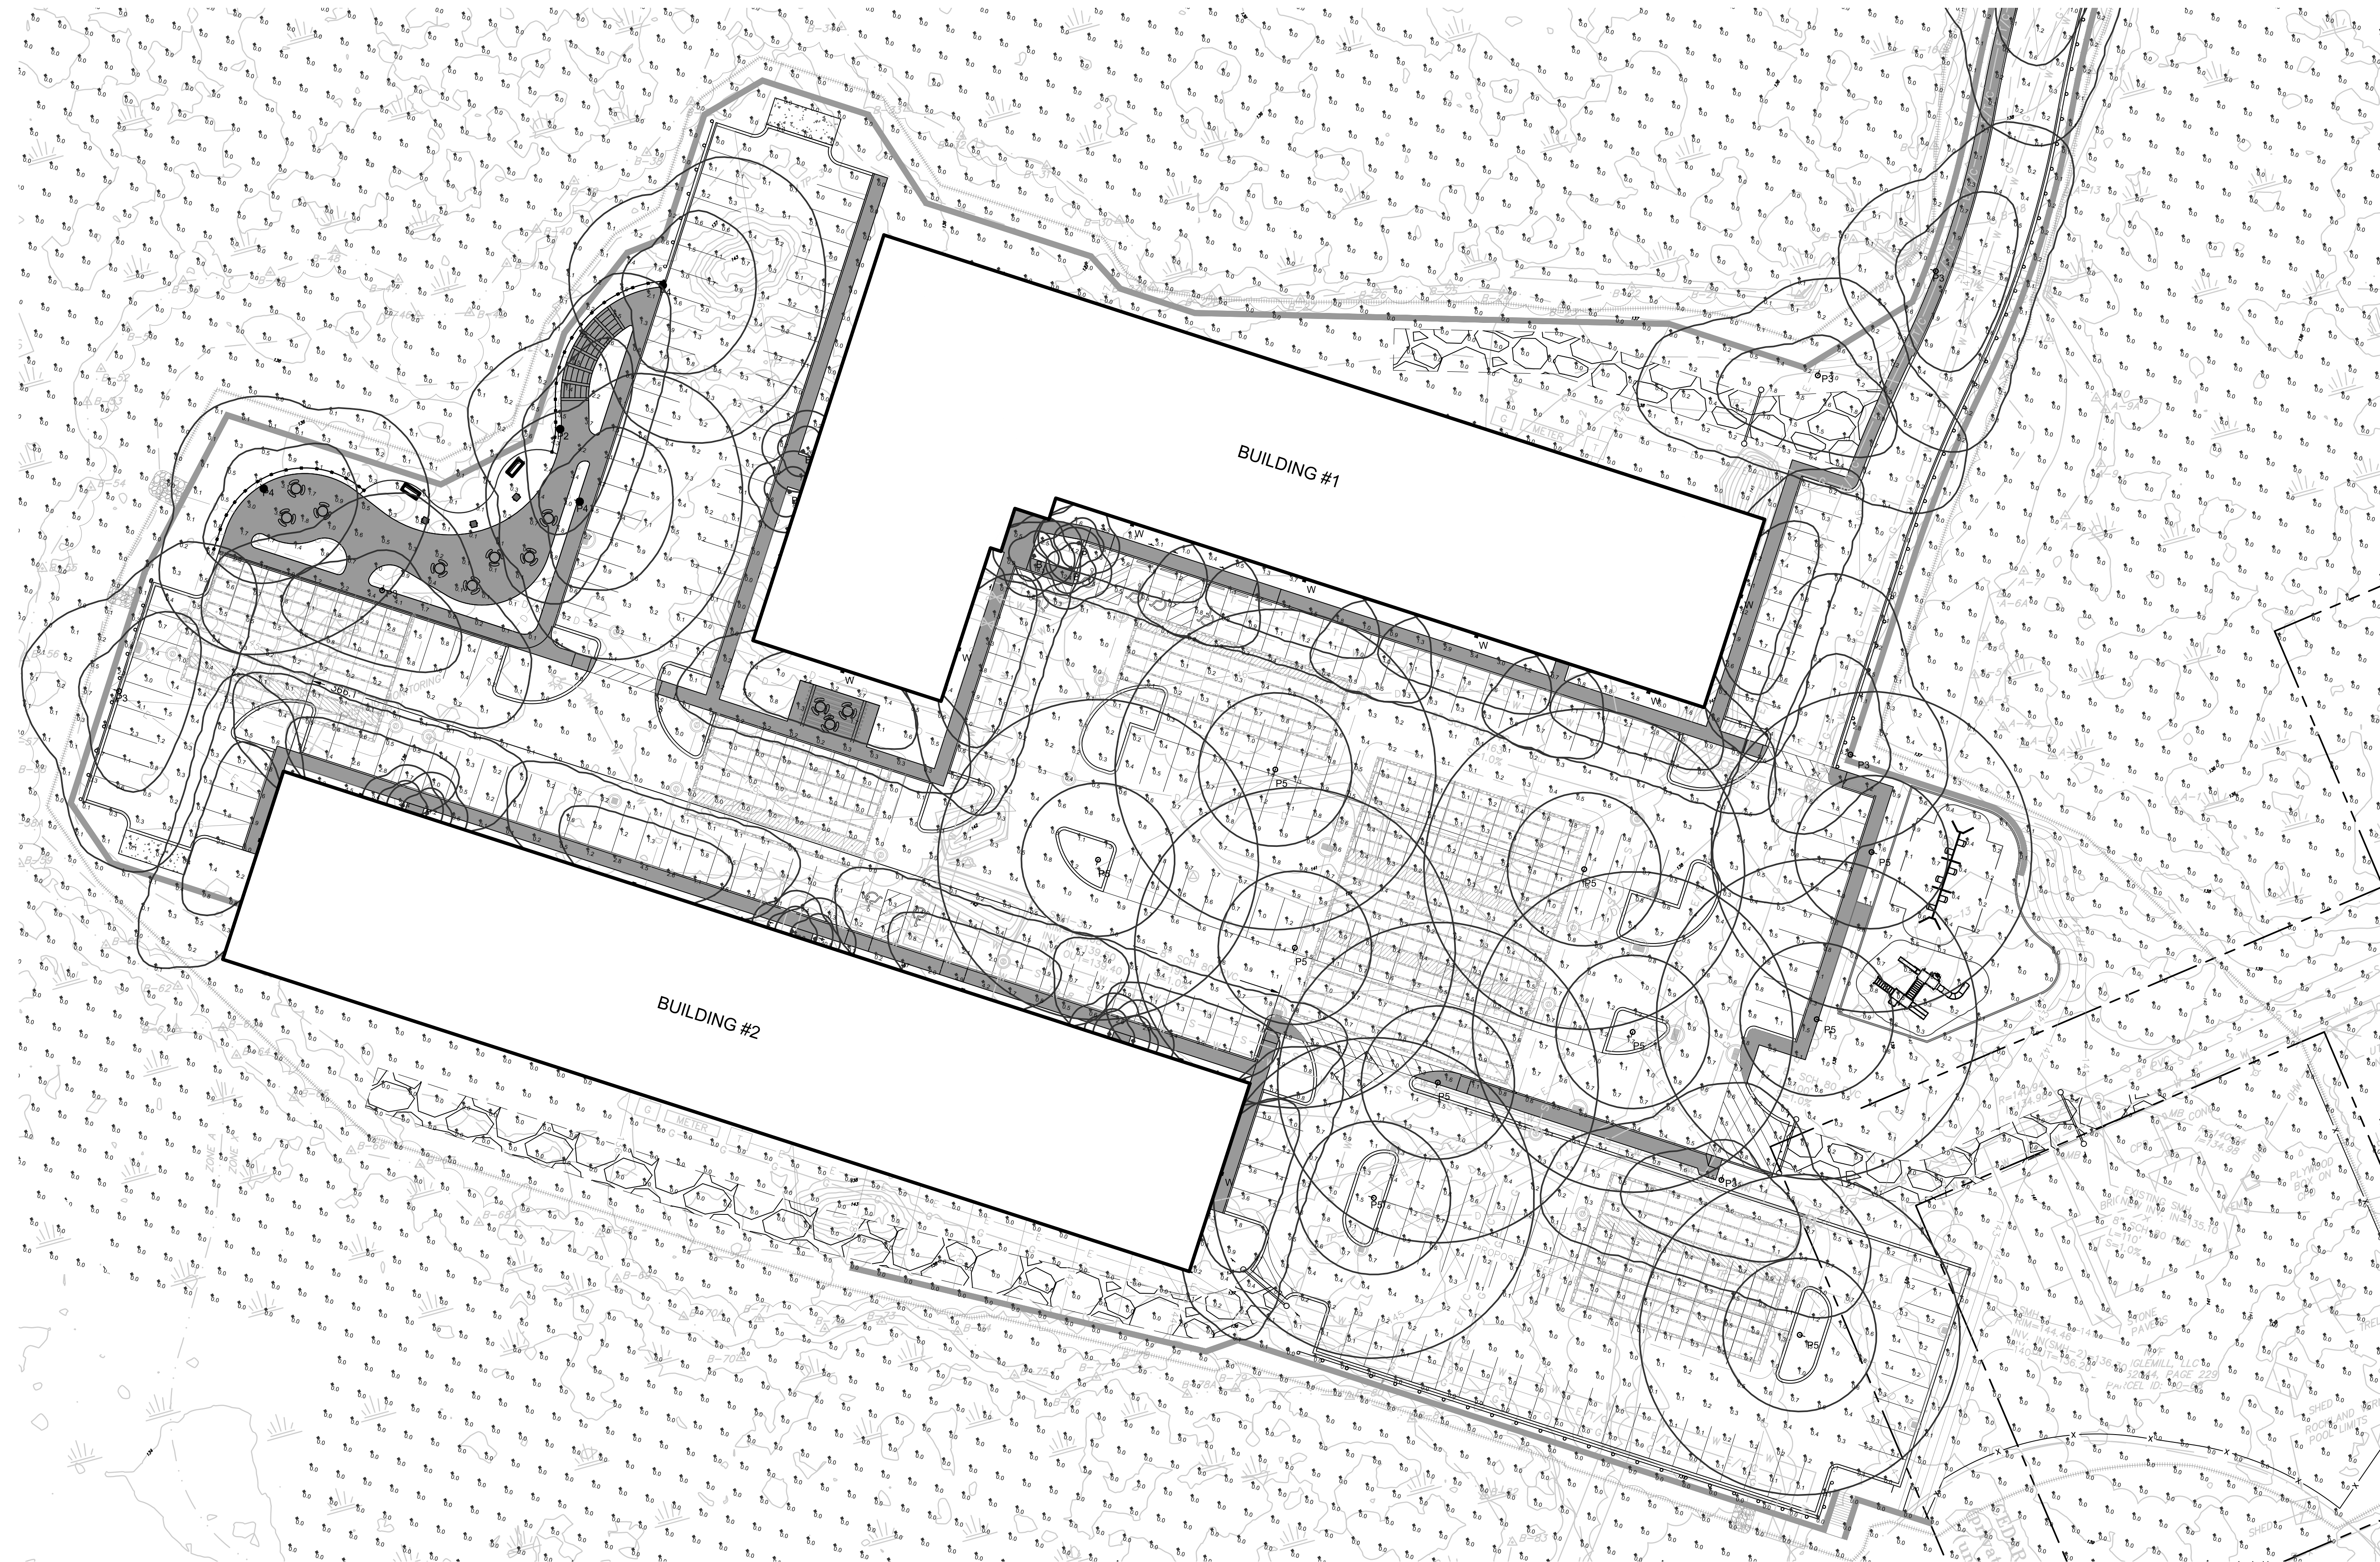

JOB NAME: SHINGLE HILL
APEX LIGHTING SOLUTIONS
WORKPLANE/CALC PLANE: AT FINISH GRADE
MOUNTING HEIGHT: SEE LUMINAIRE SCHEDULE
APPS: LED
SALES: SS

Qty	Label	Arrangement	Lumens	Input Watts	LLF	BUG Rating	Description
11	B	Single	2101	27.19	0.850	B1-U0-G0	SELUX IBL-3.5-4QD-30-XX-UNV
1	P2	Single	4715	35.2	0.850	B1-U0-G1	HADCO CXF6-32-G3-T-x-2-730-x-3 / MOUNTED @ 15FT AFG TO BOF
11	P3	Single	4801	35.2	0.850	B1-U0-G1	HADCO CXF6-32-G3-T-x-3-730-x-3 / MOUNTED @ 15FT AFG TO BOF
3	P4	Single	4850	35.2	0.850	B1-U0-G1	HADCO CXF6-32-G3-T-x-4-730-x-3 / MOUNTED @ 15FT AFG TO BOF
10	P5	Single	4515	35.2	0.850	B3-U0-G1	HADCO CXF6-32-G3-T-x-5-730-x-3 / MOUNTED @ 15FT AFG TO BOF
13	W	Single	3687	34.3	0.850	B1-U0-G1	STONCO LPW16-30-WW-G3-3-UNV-FINISH / WALL MOUNTED @ 12FT AFG TO BOF

Calculation Summary						
Label	Grid Height	Avg	Max	Min	Avg/Min	Max/Min
CalcPts_1	0	0.14	41.2	0.0	N.A.	N.A.

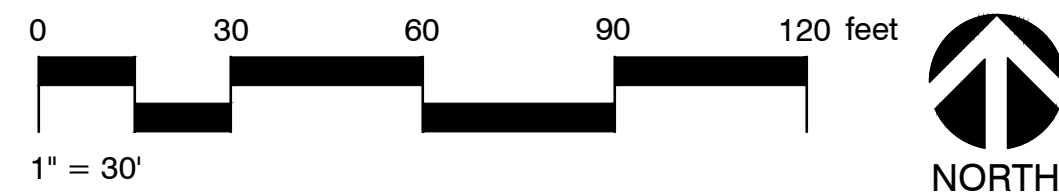

STAMP



PROJECT NAME

SHINGLEMILL
APARTMENTS

PROJECT ADDRESS

75-79 POND STREET
ROCKLAND, MA 02370

NO.	REVISIONS	DATE
1	ENGINEERING EDITS	9/23/2022
	ENGINEERING EDITS	7/21/2023

SUBMITTAL

DATE

DRAWN BY:

JL

CHECKED BY:

KB

DATE ISSUED:

JULY 2023

SCALE:

1" = 30'

PROJ. NO.

R1018.1

SHEET TITLE

SITE LIGHTING
PLAN 2

SHEET NO.

LE1.1



OVERALL SITE SCHEDULE

JOB NAME: SHINGLE HILL
APEX LIGHTING SOLUTIONS
WORKPLANE/CALC PLANE: AT FINISH GRADE
MOUNTING HEIGHT: SEE LUMINAIRE SCHEDULE
APPS: LED
SALES: SS

Qty	Label	Arrangement	Lumens	Input Watts	LLF	BUG Rating	Description
11	B	Single	2101	27.19	0.850	B1-UG-G0	SELUX IBL-3 5-40D-30-XX-UNV
1	P2	Single	4715	35.2	0.850	B1-UG-G1	HADCO CXP8-32-G3-T-x-2-730-x-3 / MOUNTED @ 15FT AFG TO BOF
11	P3	Single	4601	35.2	0.850	B1-UG-G1	HADCO CXP8-32-G3-T-x-3-730-x-3 / MOUNTED @ 15FT AFG TO BOF
3	P4	Single	4650	35.2	0.850	B1-UG-G1	HADCO CXP8-32-G3-T-x-4-730-x-3 / MOUNTED @ 15FT AFG TO BOF
10	P5	Single	4515	35.2	0.850	B3-UG-G1	HADCO CXP8-32-G3-T-x-5-730-x-3 / MOUNTED @ 15FT AFG TO BOF
13	W	Single	3687	34.3	0.850	B1-UG-G1	STONCO LPW16-30-WW-G3-3-UNV-FINISH / WALL MOUNTED @ 12FT AFG TO BOF

Calculation Summary		Grid Height	Avg	Max	Min	Avg/Min	Max/Min
Label							
CalcPis_1		0	0.14	41.2	0.0	N.A.	N.A.

CONS:
SCIEN


GENERAL NOTES:

- ALL PLANT MATERIAL MUST BE TAGGED IN THE GROUND, AT THE NURSERY BY THE LANDSCAPE ARCHITECT. ALL PLANT MATERIAL SHALL BE COMMERCIALY OBTAINED AND SHALL MEET THE AMERICAN ASSOCIATION OF NURSERYMAN STANDARDS FOR NURSERY STOCK, LATEST EDITION, AND ITS AMENDMENTS. PLANT ONLY DURING SEASON NORMAL TO THE PARTICULAR VARIETY. ALL PLANT INSPECTIONS WILL BE AT THE EXPENSE OF THE CONTRACTOR. PERMANENT SEALS WILL BE REQUIRED.
- PLANTING BEDS SHALL BE EXCAVATED TO A MINIMUM DEPTH OF 12" AND NEW LOAM AND COMPOST (50/50 MIX) SHALL BE INCORPORATED INTO THE PLANTING BED TO MEET SURROUNDING GRADES UNLESS OTHERWISE NOTED OR DETAILED. COVER ALL PLANTING BEDS WITH 3" SHREDDED HARDWOOD BARK MULCH WITHIN A SEVENTY-TWO HOUR PERIOD AFTER PLANTING. SEE PLAN FOR BED LAYOUT.
- ALL EXISTING AND PROPOSED TREES SHOWN IN LAWN AREAS SHALL RECEIVE A 5' DIAMETER MULCH BED. MULCH SHALL BE PLACED TO A DEPTH OF 3". REMOVE ALL SOD, ROOTS, STICKS AND STONES PRIOR TO PLACEMENT OF MULCH.
- ALL PLANT MATERIALS FURNISHED BY THE CONTRACTOR SHALL BE GUARANTEED FOR A PERIOD OF ONE YEAR FROM FINAL ACCEPTANCE OF LANDSCAPE WORK.
- STAKE ALL TREES OVER 5' AS SHOWN ON DETAILS. REMOVE STAKES AT THE END OF THE GUARANTEE PERIOD.
- THE CONTRACTOR IS RESPONSIBLE FOR KEEPING THE SITE CLEAN OF MISCELLANEOUS DEBRIS THROUGHOUT THE CONSTRUCTION PERIOD. ALL WASTE MATERIAL IS TO BE DISPOSED OF IMMEDIATELY TO AN OFF-SITE LOCATION, UNLESS OTHERWISE INDICATED ON THE PLANS.
- THE CONTRACTOR SHALL PERFORM ALL WORK IN ACCORDANCE WITH ALL LOCAL, STATE, AND FEDERAL REGULATIONS, AND SHALL OBTAIN ALL NECESSARY PERMITS FOR THIS PROJECT.
- LOAM: LOAM MOVED DURING THE COURSE OF CONSTRUCTION SHALL BE RETAINED AND DISTRIBUTED WITHIN THE SITE IN ACCORDANCE WITH THE LANDSCAPE PLAN. STOCKPILED LOAM SHALL NOT BE MIXED WITH ANY SUBSOIL, NOXIOUS WEEDS OR UNSUITABLE MATERIALS. ALL EXCESS LOAM SHALL REMAIN ON THE PROPERTY OF THE OWNER. NEW LOAM IF REQUIRED TO PROVIDE THE SPECIFIED DEPTH, SHALL BE A FERTILE, FRIABLE MEDIUM TEXTURED SANDY LOAM FREE OF MATERIAL TOXIC TO HEALTHY PLANT GROWTH. LOAM SHALL ALSO BE FREE OF ALL STUMPS, ROOTS, STONES AND OTHER EXTRANEOUS MATTER AN INCH (1") OR GREATER IN DIAMETER. THE PH SHALL BE BETWEEN 6.5 AND 7.5. ORGANIC CONTENT SHALL BE A MINIMUM OF 5%.
- LAWN PREPARATION: REMOVE ALL DEBRIS AND OTHER INORGANIC MATERIALS ON THE PREPARED SUBGRADE. RESHAPE AND DRESS ANY DAMAGED OR ERODED AREA PRIOR TO SPREADING THE LOAM. SCARIFY AND LOOSEN SUBGRADE IN ANY AREAS WHERE COMPACTION MAY HAVE OCCURRED. SPREAD STOCKPILED AND OFF-SITE LOAM ON ALL DISTURBED AREAS TO PRODUCE A DEPTH OF 4" UNLESS OTHERWISE NOTED ON THE PLANS. FINE GRADE LOAMED AREAS TO PRODUCE A SMOOTH AND UNBROKEN FINISH GRADE TO THE REQUIRED DEPTH. APPLY A STARTER FERTILIZER (10-20-10) AT A RATE OF 20 LBS. PER 1000 SQUARE FEET AND LIME AT A RATE OF 40 LBS. PER 1000 SQUARE FEET UNLESS OTHERWISE NOTED ON THE PLANS OR IN THE SPECIFICATIONS. ONCE SPREAD, THE FERTILIZER AND LIME SHALL BE THOROUGHLY INCORPORATED INTO THE LOAM. THE LOAM SHALL BE ROLLED, AND DEPRESSION SHALL BE TOP DRESSED AND RAKED TO CREATE A SMOOTH SURFACE.
- SEEDING: SEEDING SHALL TAKE PLACE BETWEEN MARCH 15 AND MAY 31 OR AUGUST 15 AND OCTOBER 15 ONLY. SEED SHALL BE PURE LIVE FRESH SEED FROM COMMERCIAL SOURCES MEETING AND LABELED IN ACCORDANCE WITH STATE AND FEDERAL RULES AND REGULATIONS. THE SEED MIXTURE SHALL BE AS NOTED ON THIS SHEET.

SEEDED AREAS SHALL, AT A MINIMUM, INCLUDE ALL AREAS OF THE SITE THAT HAVE BEEN DISTURBED OR ARE BARREN UNLESS OTHERWISE NOTED ON THE PLANS. SEED SHALL BE APPLIED AT THE RATES INDICATED PER SEED MIX.
- PROTECTION OF EXISTING PLANTINGS: MAXIMUM EFFORT SHOULD BE MADE TO SAVE TREE OR OTHER PLANT SPECIMENS WHICH ARE LARGE FOR THEIR SPECIES, RARE TO THE AREA, OR OF SPECIAL HORTICULTURAL OR LANDSCAPE VALUE. CONTACT OWNER/LANDSCAPE ARCHITECT BEFORE REMOVING ANY SPECIMEN OF THIS TYPE UNLESS OTHERWISE NOTED ON THE PLANS. NO MATERIAL OR TEMPORARY SOIL DEPOSITS SHALL BE PLACED WITHIN THE DRIP LINE OF SHRUBS OR TREES DESIGNATED ON THE LANDSCAPE PLAN TO BE RETAINED. PROTECTIVE BARRIERS ARE TO BE INSTALLED AROUND EACH PLANT AND/OR GROUP OF PLANTS THAT ARE TO REMAIN ON THE SITE. BARRIERS SHALL NOT BE SUPPORTED BY THE PLANTS THEY ARE PROTECTING, BUT SHALL BE SELF SUPPORTING. THEY SHALL BE OF MINIMUM OF FOUR FEET (4') HIGH AND CONSTRUCTED OF A DURABLE MATERIAL, SUCH AS SNOW OR SILT FENCE, THAT WILL LAST UNTIL CONSTRUCTION IS COMPLETED.
- PRUNING: THE CONTRACTOR SHALL EMPLOY A CERTIFIED ARBORIST TO PRUNE ANY EXISTING ROOTS OR BRANCHES CAREFULLY PRUNE BRANCHES IN THE WAY OF CONSTRUCTION BY USING ONLY APPROVED METHODS AND TOOLS. THE USE OF AXES FOR TRIMMING OR SPURS FOR CLIMBING WILL NOT BE PERMITTED.
- EXISTING UTILITIES: IN ACCORDANCE WITH DIG-SAFE LAW (1-800-225-4977), THE CONTRACTOR SHALL CONTACT ALL APPLICABLE UTILITY COMPANIES AND VERIFY UTILITY LINE LOCATIONS. THE CONTRACTOR SHALL BE SOLELY RESPONSIBLE FOR ANY/ALL UTILITY DAMAGE. RECORD LOCATIONS OF DIG-SAFE UTILITY LINE MARKINGS ON PROJECT RECORD DOCUMENTS.
- DISTURBED AREAS: ANY AREAS DISTURBED DURING THE COURSE OF CONSTRUCTION ARE TO BE RESTORED TO ORIGINAL (OR BETTER) CONDITION BY CONTRACTOR BEFORE COMPLETION OF THE PROJECT, AND ARE SUBJECT TO APPROVAL BY LANDSCAPE ARCHITECT AND OWNER. ALL GRASS AREAS DISTURBED DURING CONSTRUCTION SHALL BE YORK RAKED TO REMOVE STONES AND LOAMED AND SEEDED AS PER SPECIFICATIONS.
- LAYOUT: ALL NOTES AND DIMENSIONS ARE TYPICAL UNLESS OTHERWISE NOTED. ALL DIMENSIONS ARE SQUARE (PARALLEL OR PERPENDICULAR) UNLESS OTHERWISE NOTED. THE CONTRACTOR SHALL NOTIFY THE OWNER/OWNER'S REPRESENTATIVE IMMEDIATELY IN THE EVENT OF ANY DISCREPANCIES FOUND IN THE CONTRACT DOCUMENTS AND/OR IN THE FIELD, OR OF CONDITIONS UNCOVERED IN THE WORK WHICH ARE NOT REFLECTED IN THE PLANS.
- DRAINAGE SYSTEMS: CONTRACTOR IS RESPONSIBLE FOR GENERAL CLEAN-OUT OF ALL CATCH BASINS, MANHOLES, AND/OR OTHER DRAINAGE FEATURES ON THE SITE WHICH HAVE ACCUMULATED SEDIMENT AS A RESULT OF CONSTRUCTION ACTIVITIES.
- CLEANING: CONTRACTOR IS RESPONSIBLE FOR KEEPING SITE CLEAN OF MISCELLANEOUS DEBRIS THROUGHOUT THE CONSTRUCTION PERIOD. ALL WASTE MATERIAL IS TO BE DISPOSED OF IMMEDIATELY TO AN OFF-SITE LOCATION, UNLESS OTHERWISE INDICATED ON THE PLAN.

NOTES:

- REFER TO LP1.1 AND LP1.2 FOR PLANTING ENLARGEMENTS.
- REFER TO CIVIL ENGINEERING PLANS FOR ALL GRADING, DRAINAGE AND UTILITIES.

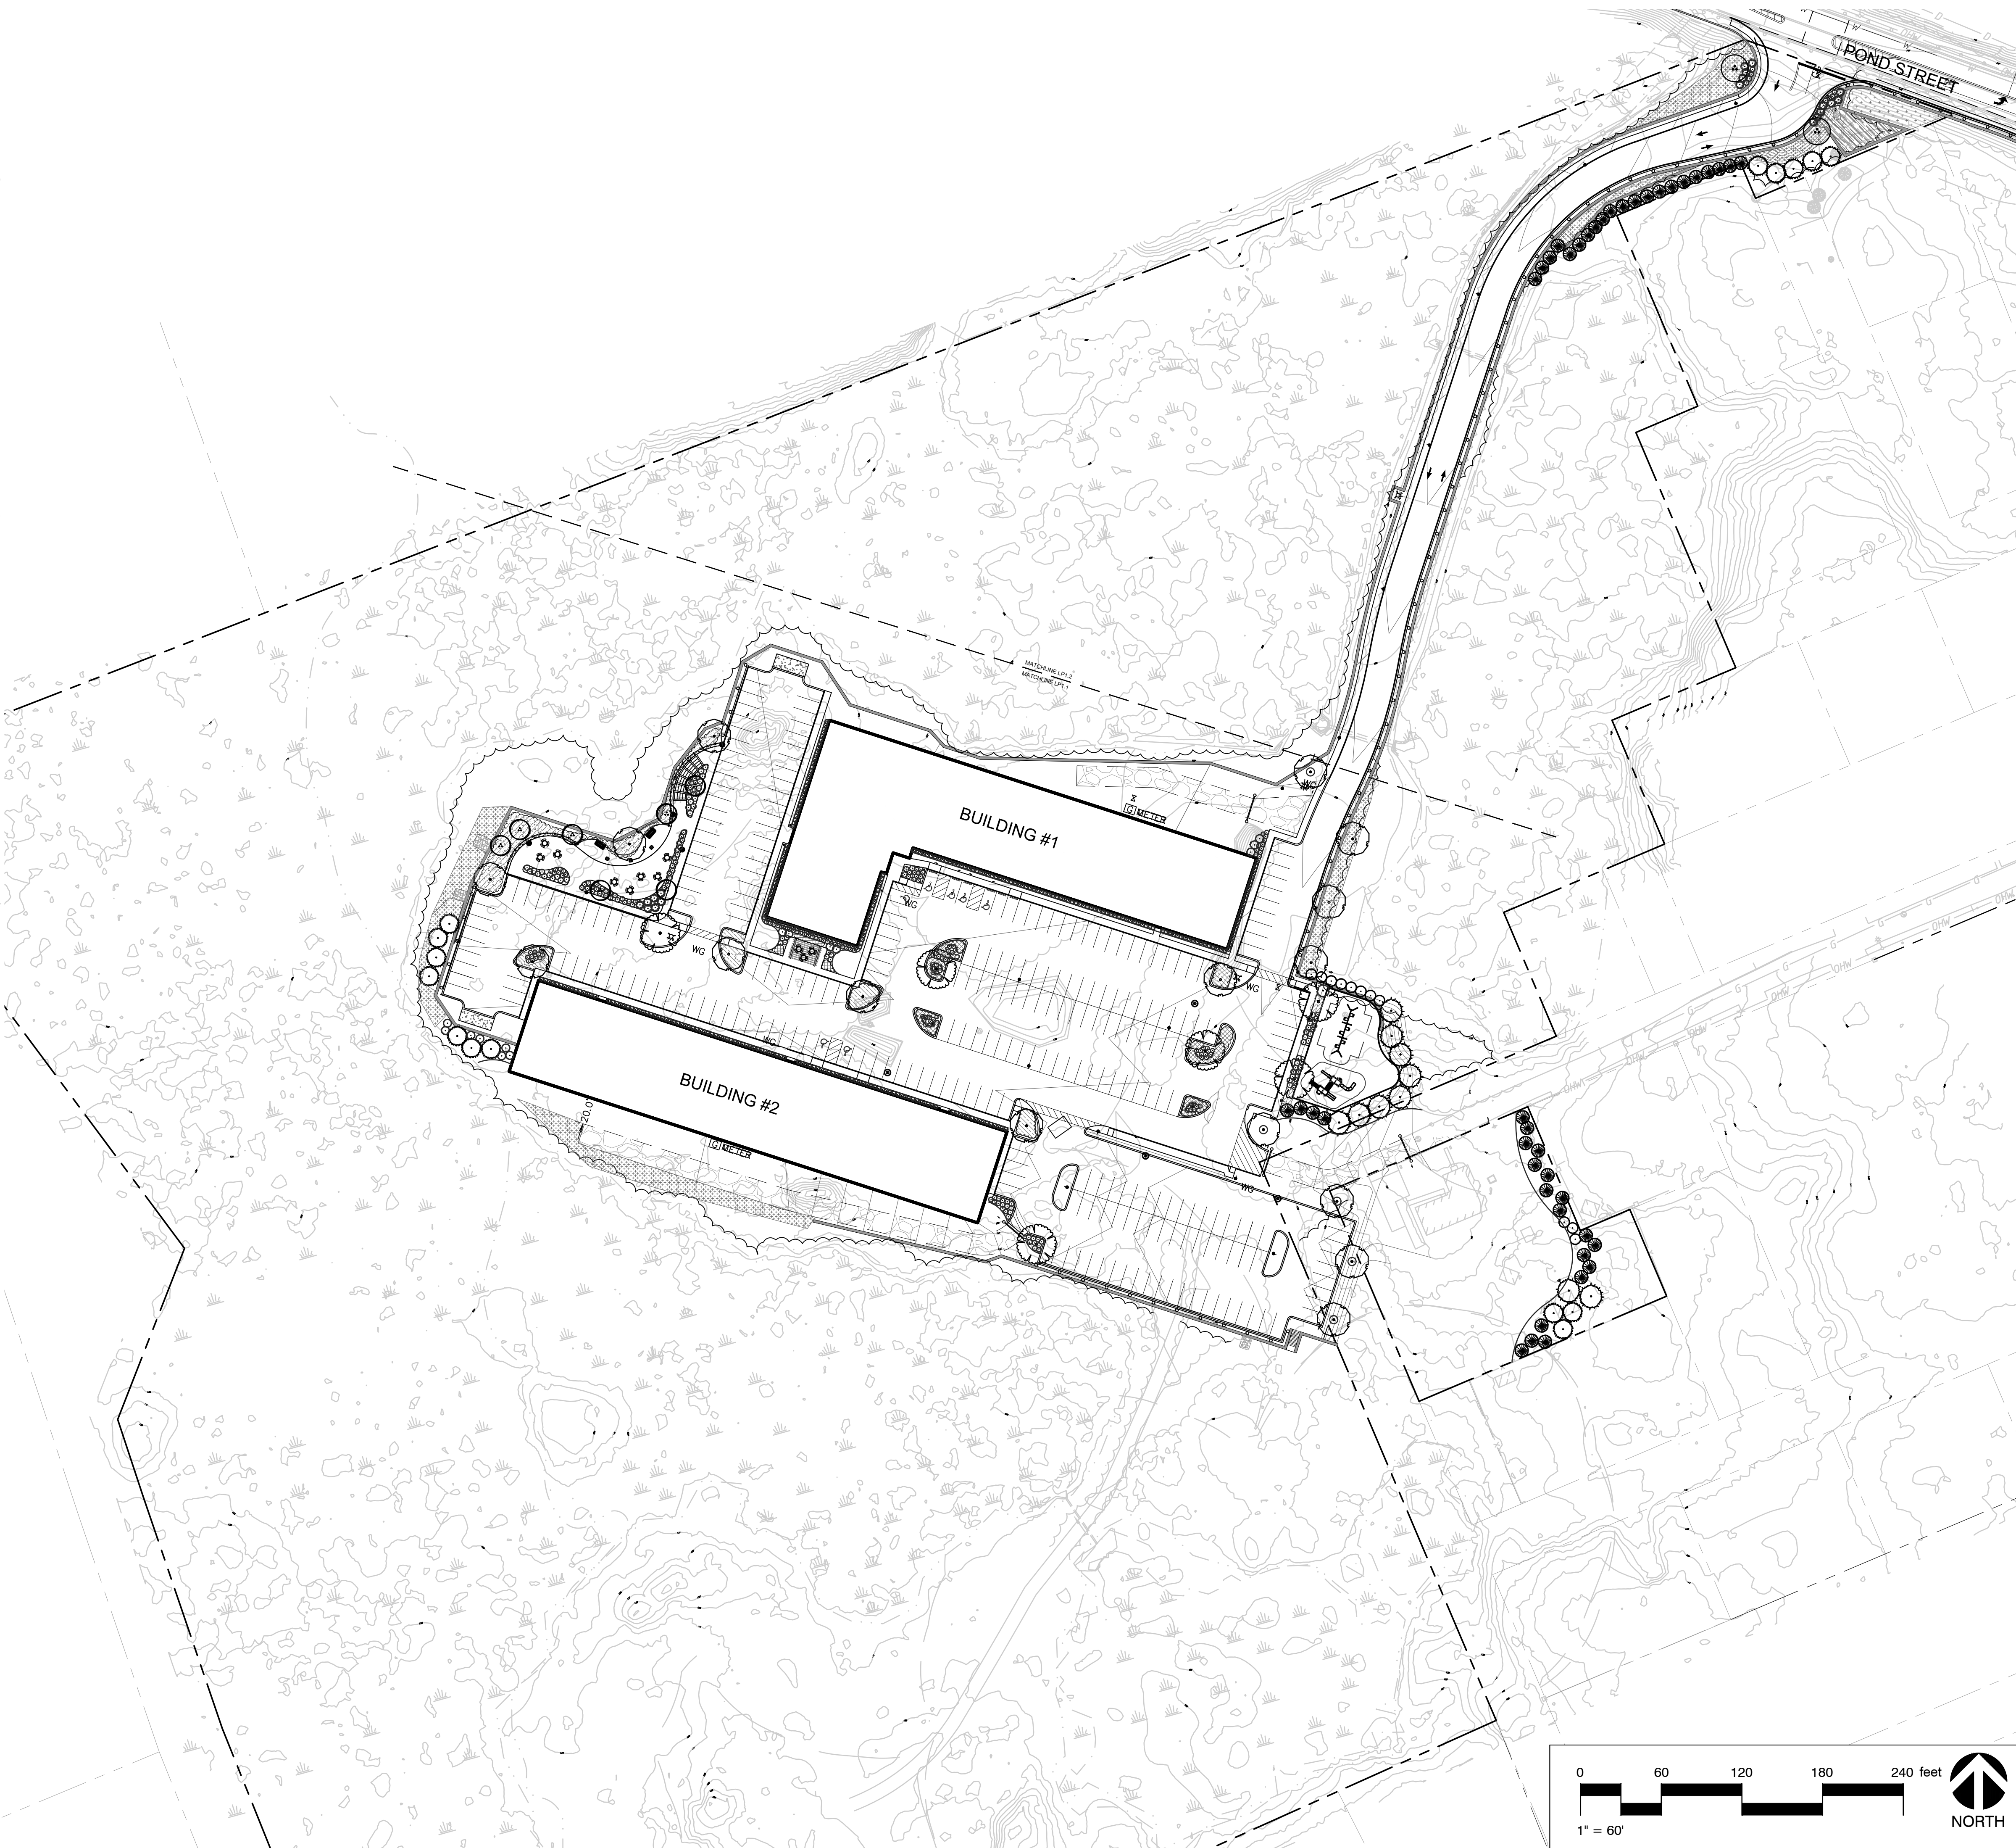

STAMP



PROJECT NAME

SHINGLEMILL
APARTMENTS

PROJECT ADDRESS

75-79 POND STREET
ROCKLAND, MA 02370

NO.	REVISIONS	DATE
1	ENGINEERING EDITS	9/23/2022
	ENGINEERING EDITS	7/21/2023

SUBMITTAL

DATE

DRAWN BY: JL	CHECKED BY: KB
DATE ISSUED: JULY 2023	SCALE: 1" = 60'
PROJ. NO. R1018.1	

SHEET TITLE
OVERALL PLANTING
PLAN

SHEET NO.
LP1.0

N/F
SHINGLEMILL, LLC
BOOK 51016, PAGE 303
PARCEL NO. 9-13


PLANT SCHEDULE LP1.0

TREES	BOTANICAL / COMMON NAME	CONT	SIZE	QTY
AA	Acer rubrum 'Autumn Glory' / Autumn Glory Maple	B&B	2'-2.5' Cal.	18'
BW	Betula populifolia 'Whitespire Sr.' / Gray Birch	B&B	Multi-stem	7
GS	Olethia tiacanthos 'Shademaster' / Shademaster Locust	B&B	2'-2.5' Cal.	6
JC	Juniperus virginiana 'Canaertii' / Caneertii Juniper	B&B	6/7'	10
PS	Pinus strobus / White Pine	B&B	3" Cal.	10
PF	Pinus strobus 'Fastigata' / Pyramidal White Pine	B&B	7/8'	11
TG	Thuja occidentalis 'Green Giant' / Green Giant Arborvitae	B&B	7/8'	22
SHRUBS	BOTANICAL / COMMON NAME	CONT	SIZE	QTY
AA2	Aronia melanocarpa 'Autumn Magic' / Autumn Magic Black Chokeberry	3 gal		7
BG	Buxus 'Green Mountain' / Green Mountain Boxwood	5 gal		312
CH	Clethra alnifolia 'Hummingbird' / Hummingbird Summersweet	5 gal		37
CK	Cornus sericea 'Kelsey' / Kelsey Dwarf Redtwig Dogwood	5 gal		133
HA	Hydrangea arborescens 'Annabelle' / Annabelle Hydrangea	5 gal		9
IS	Ilex glabra 'Shamrock' / Shamrock Inkberry Holly	5 gal		22
IV	Ilex verticillata 'Jim Dandy' / Jim Dandy Winterberry	6/7' B&B		3
IR	Ilex verticillata 'Red Sprite' / Red Sprite Winterberry	3 gal		29
JB	Juniperus chinensis 'Blue Point' / Blue Point Juniper	5/6' B&B		14
Jh	Juniperus chinensis 'Hetzl Columnaris' / Hetzl Column Juniper	5' W' B&B		1
SA	Spiraea x bumalda 'Anthony Waterer' / Anthony Waterer Spiraea	3 gal		12

GRASSES/PERENNIALS	CODE	BOTANICAL / COMMON NAME	CONT
	CK2	Calamagrostis x acutiflora 'Karl Foerster' / Feather Reed Grass	1 gal
	PH	Pennisetum alopecuroides 'Hameln' / Hameln Fountain Grass	1 gal
	PK	Pennisetum alopecuroides 'Karley Rose' / Fountain Grass	#2
	PN	Perovskia atriplicifolia 'Blue Jean Baby' / Blue Jean Baby Russian Sage	1 gal
SEED MIX	CODE	BOTANICAL / COMMON NAME	CONT
	EC	New England Erosion Control/Restoration Mix	seed
	WF	Wildflower Seed Mix / Wildflower Seed Mix	seed

- NOTES:
- REFER TO CIVIL ENGINEERING PLANS FOR ALL GRADING, DRAINAGE AND UTILITIES.
 - ALL DISTURBED AREAS NOT DESIGNATED AS SOFTSCAPE OR HARDSCAPE SHALL BE LOAM AND SEED.

STAMP

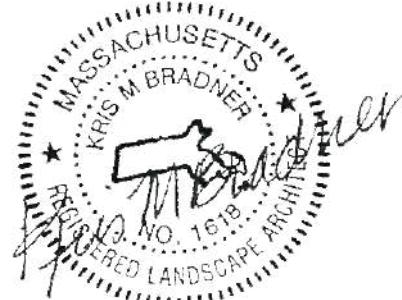

PROJECT NAME

SHINGLEMILL
APARTMENTS

PROJECT ADDRESS

75-79 POND STREET
ROCKLAND, MA 02370

NO.	REVISIONS	DATE
1	ENGINEERING EDITS	9/23/2022
2	ENGINEERING EDITS	7/21/2023
3		
4		
5		
6		

SUBMITTAL

DATE

DRAWN BY:

CHECKED BY:

JL

KB

DATE ISSUED:

SCALE:

JULY 2023

1" = 30'

PROJ. NO.


R1018.1

SHEET TITLE

PLANTING
ENLARGEMENT



SHEET NO.

LP1.1

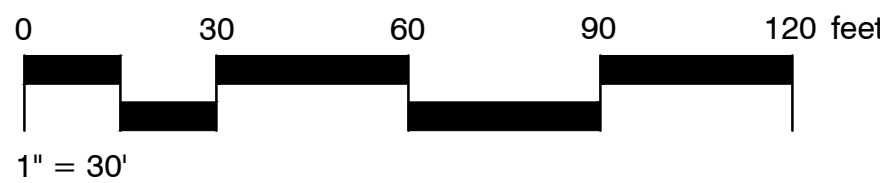

PLANT SCHEDULE LP1.1

TREES	BOTANICAL / COMMON NAME	CONT	SIZE	QTY
AG	Amelanchier x grandiflora 'Autumn Brilliance' / Autumn Brilliance Apple Serviceberry	B&B, Multi-stem	6/7'	2
TG	Thuja occidentalis 'Green Giant' / Green Giant Arborvitae	B&B	7/8'	21
TC	Tsuga canadensis / Canadian Hemlock	B&B	7/8'	5
SHRUBS	BOTANICAL / COMMON NAME	CONT	SIZE	QTY
AA2	Aronia melanocarpa 'Autumn Magic' / Autumn Magic Black Chokeberry	3 gal		12
CH	Clethra alnifolia 'Hummingbird' / Hummingbird Summersweet	5 gal		8
SEED MIX	CODE	BOTANICAL / COMMON NAME	CONT	
	EC	New England Erosion Control/Restoration Mix	seed	3,808 sf
	WN	New England Wetland Seed Mix	seed	1,046 sf

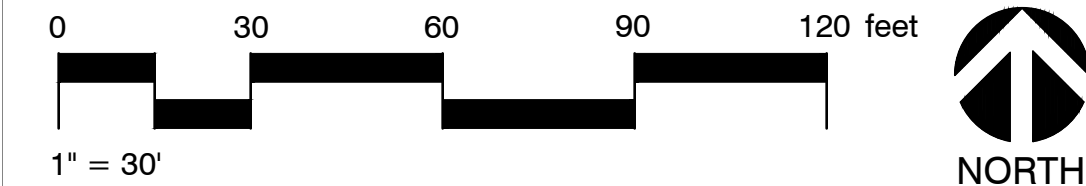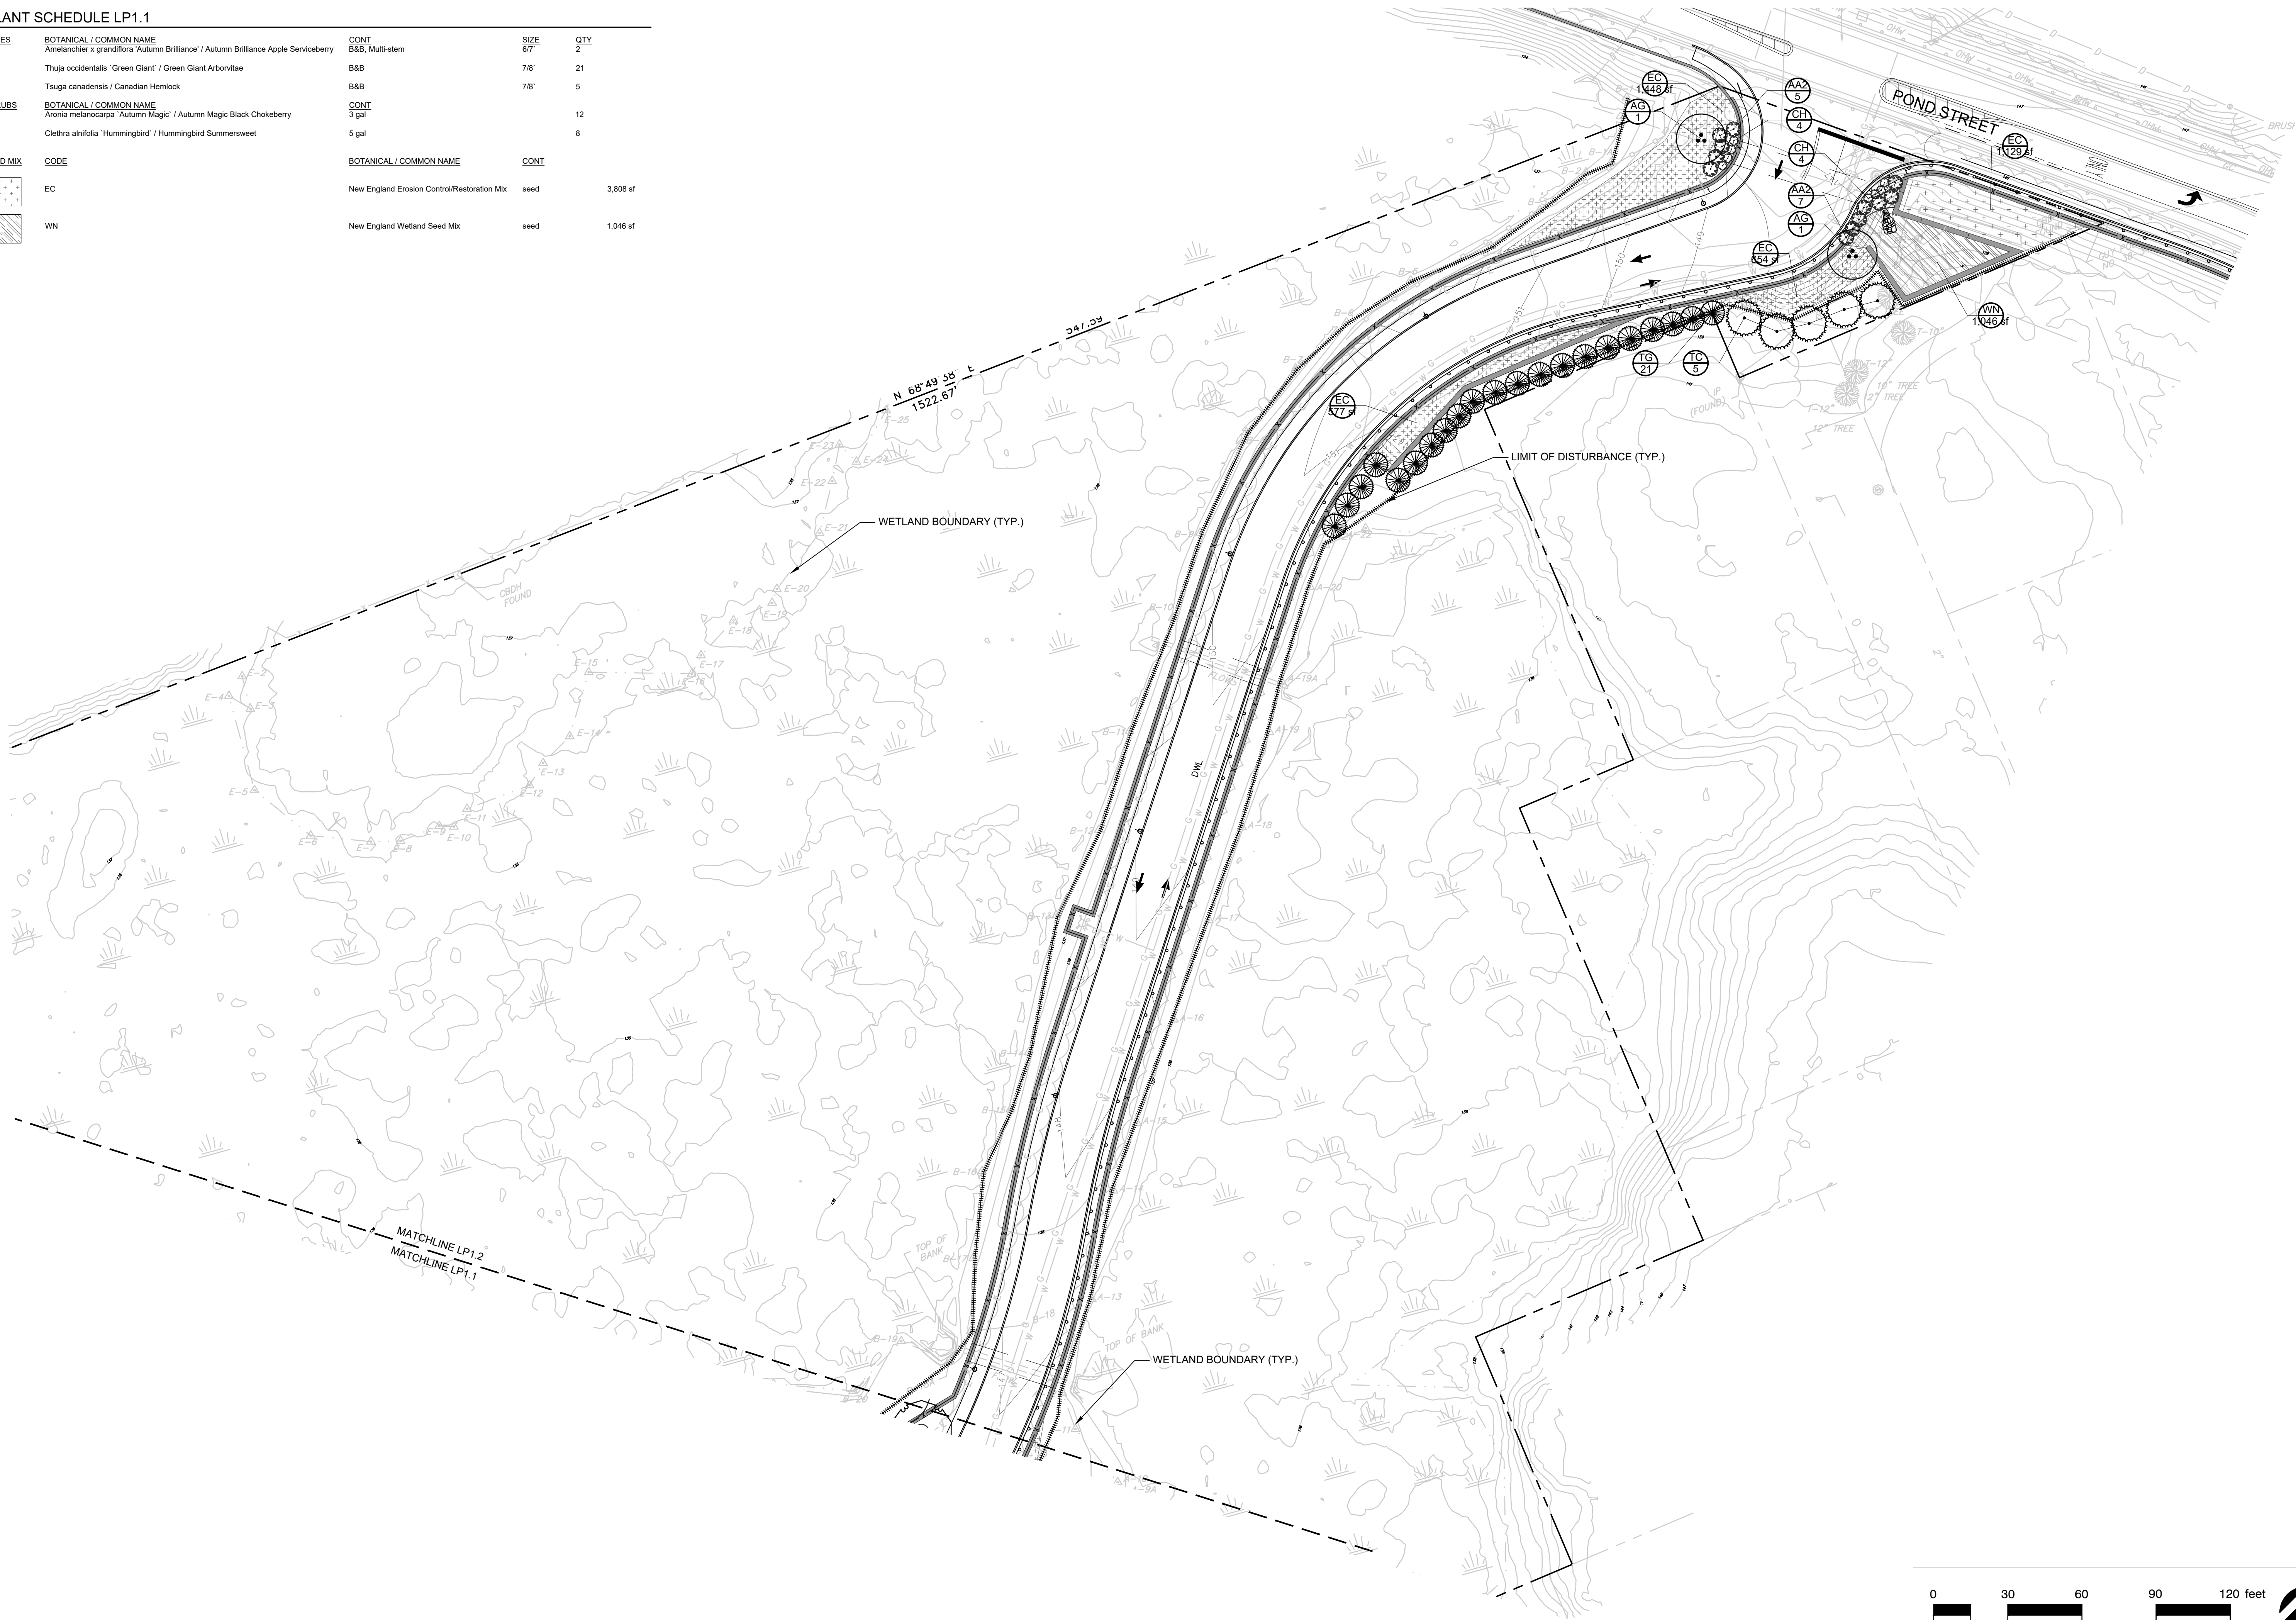

PROJECT NAME
**SHINGLEMILL
APARTMENTS**

PROJECT ADDRESS
**75-79 POND STREET
ROCKLAND, MA 02370**

NO.	REVISIONS	DATE
1	ENGINEERING EDITS	9/23/2022
2	ENGINEERING EDITS	7/21/2023
3		
4		
5		
6		

SUBMITTAL	DATE

DRAWN BY JL	CHECKED BY KB
DATE ISSUED JULY 2023	SCALE 1" = 30'

PROJ. NO.
R1018.1

SHEET TITLE
**PLANTING
ENLARGEMENT
PLAN 2**

SHEET NO.
LP1.2